




NORTH ELEVATION

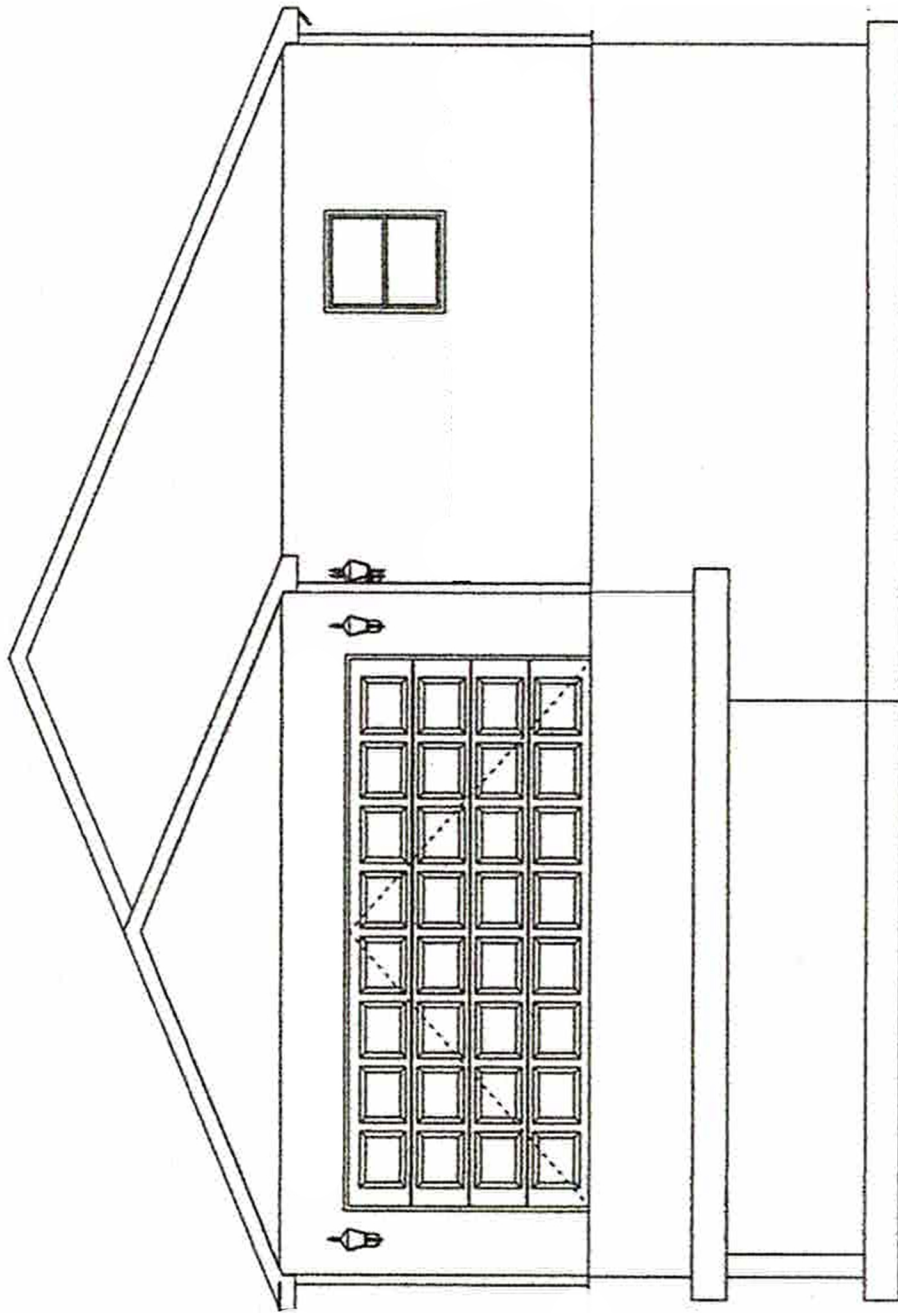


SOUTH ELEVATION

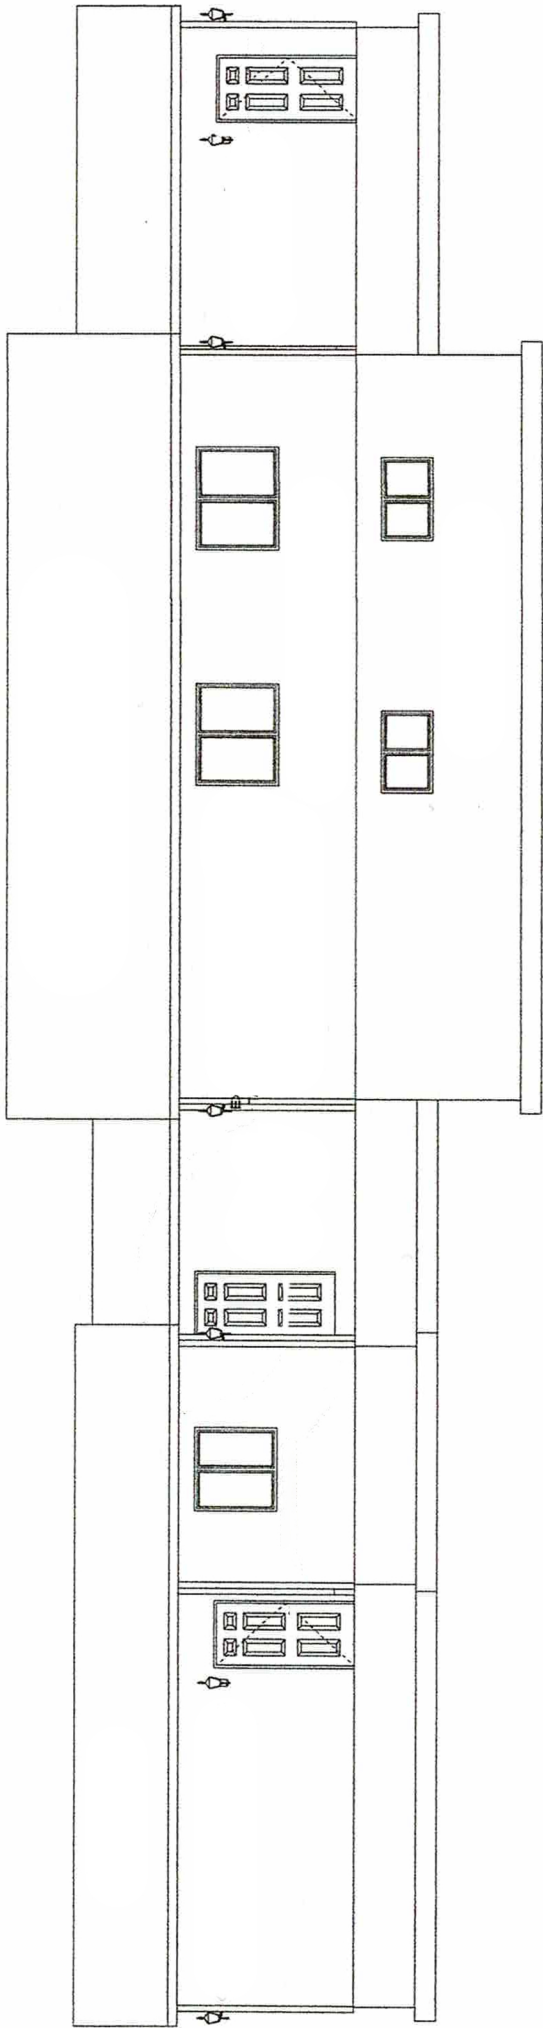


EAST ELEVATION

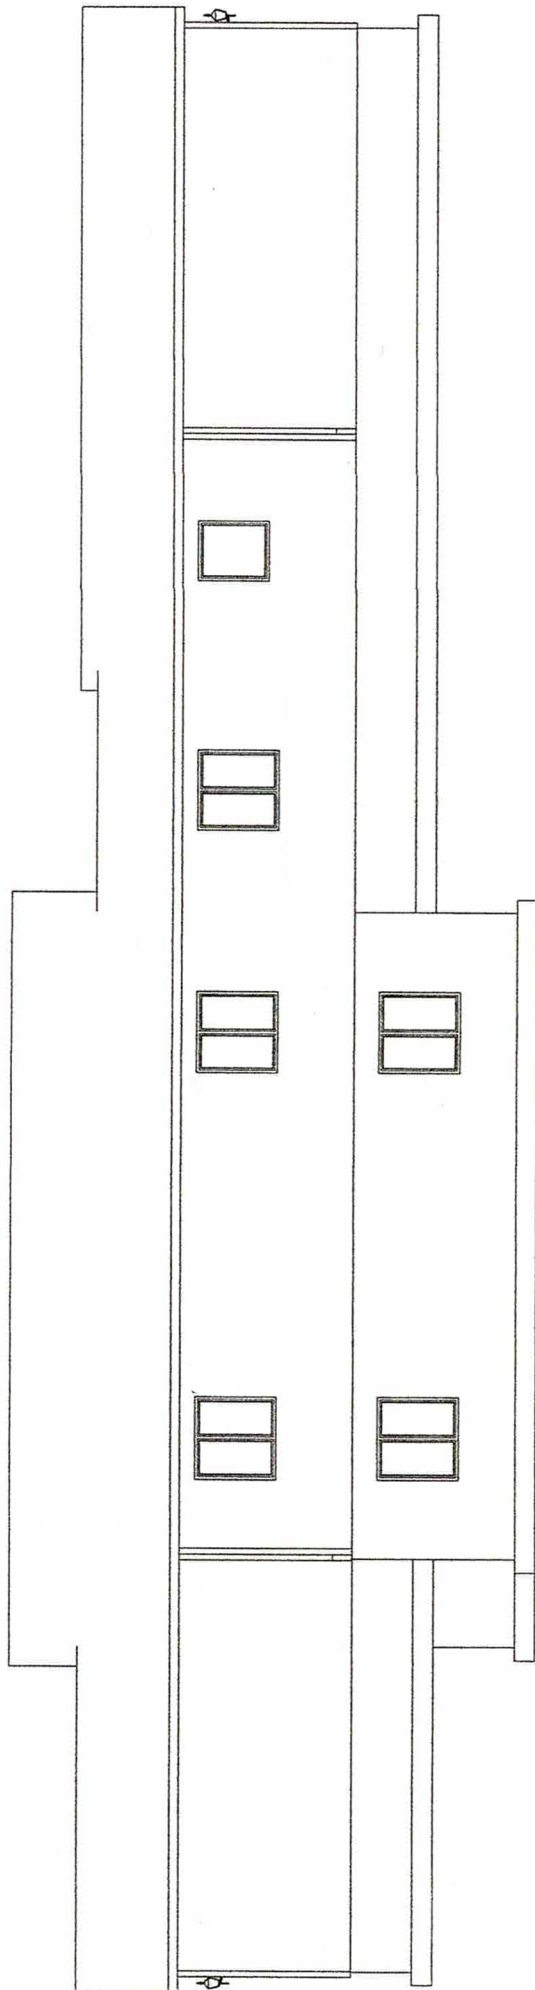


WEST ELEVATION

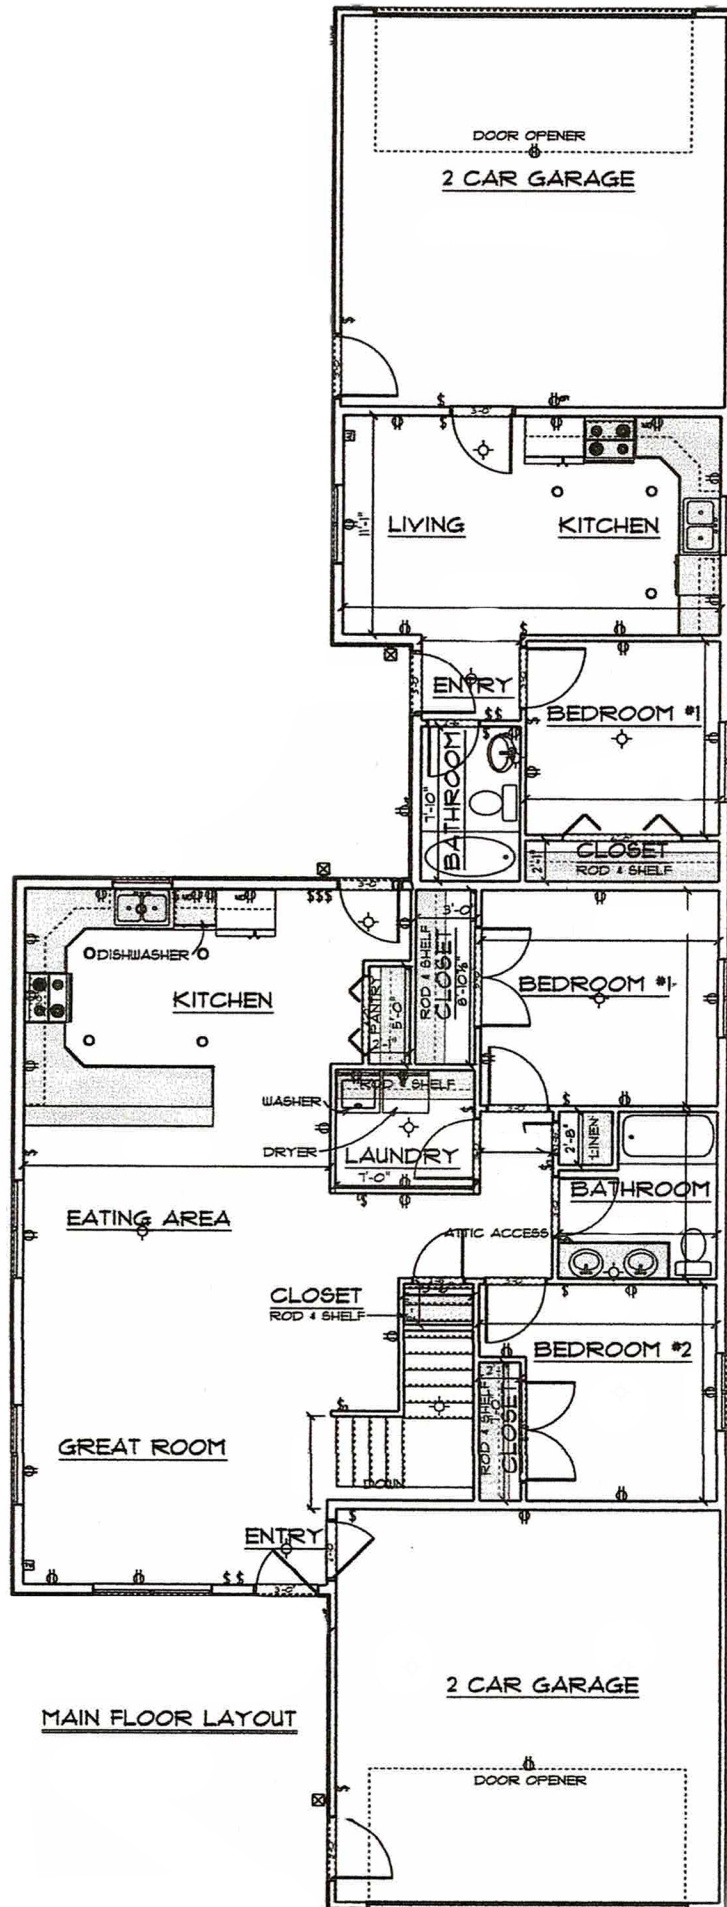


MAIN FLOOR LAYOUT

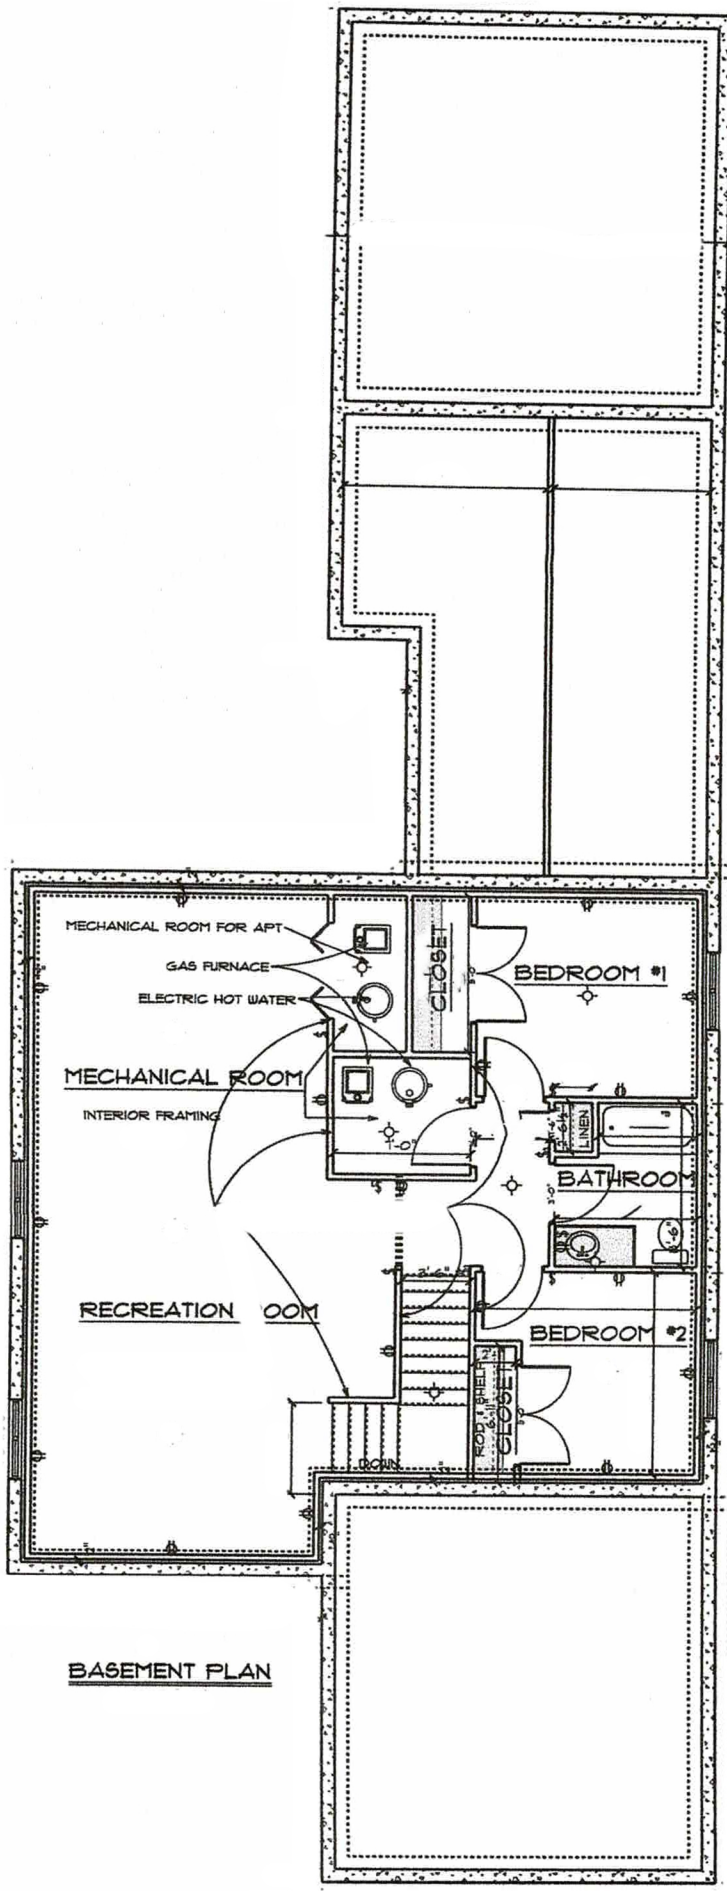

BASEMENT PLAN

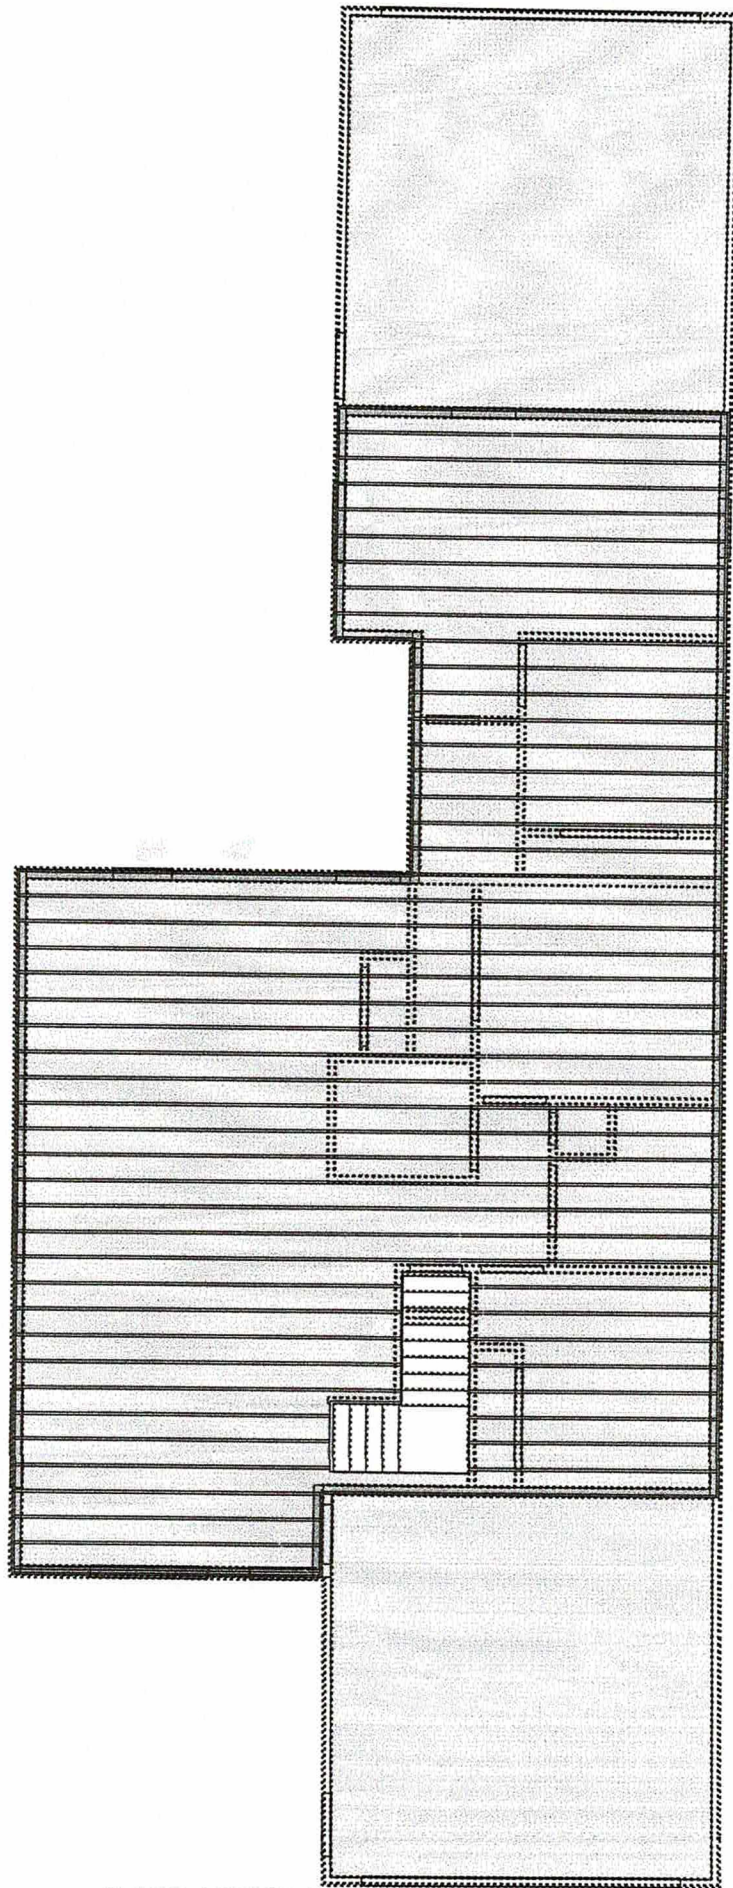


FLOOR JOIST FRAMING PLAN

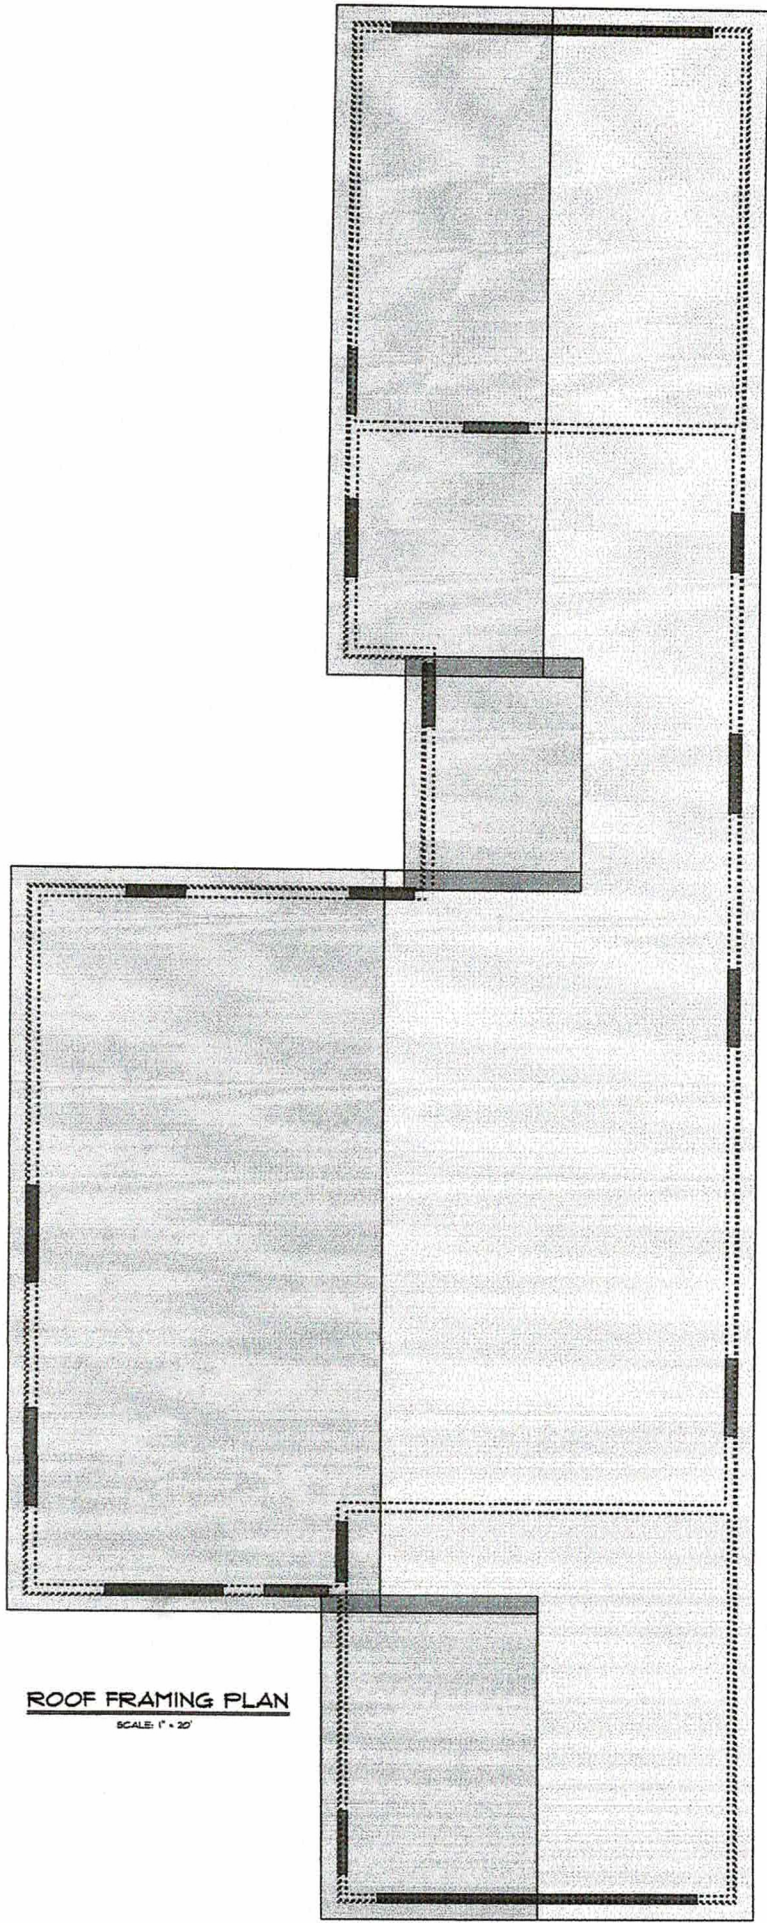


**ROOF FRAMING PLAN**  
SCALE: 1" = 20'



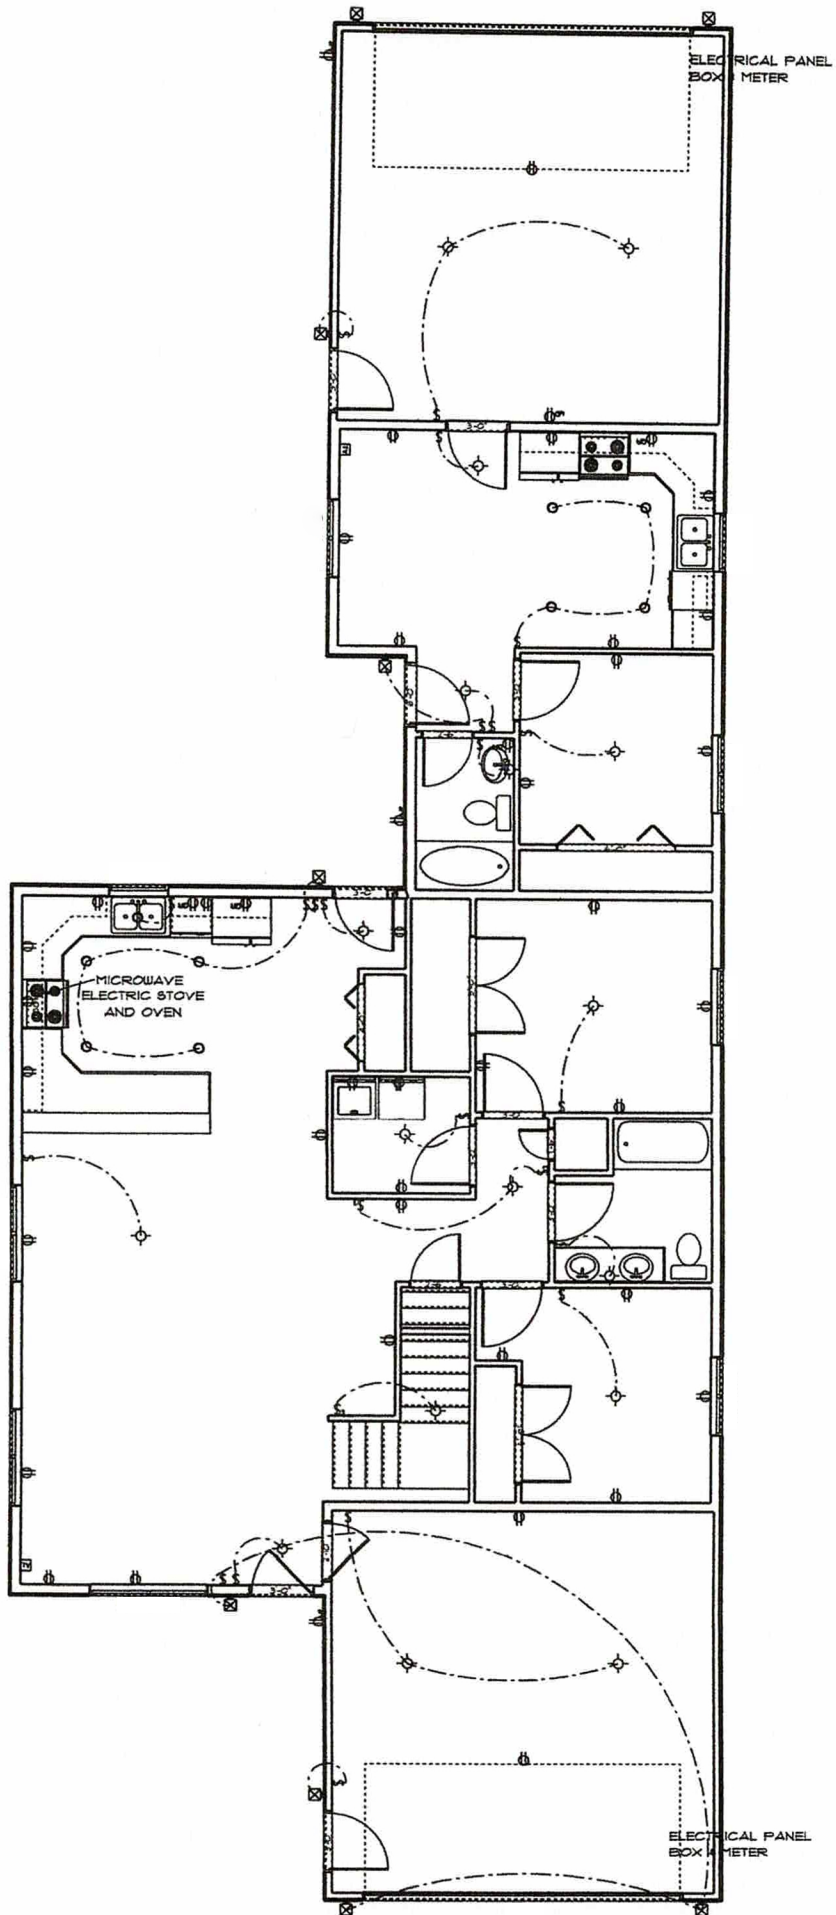

ELECTRICAL PLAN

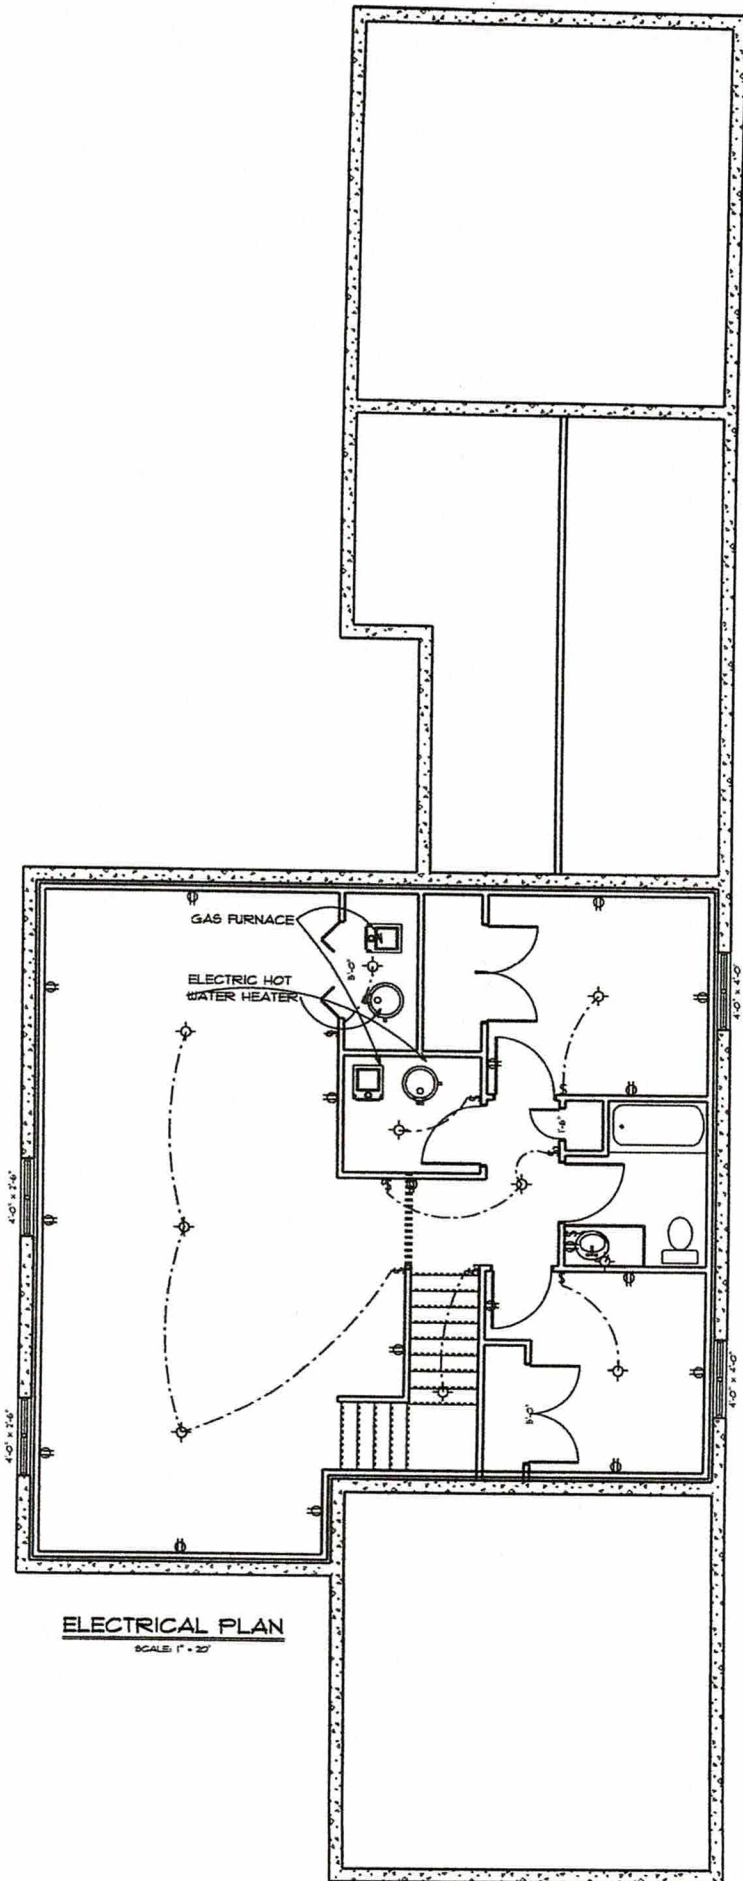

**ELECTRICAL PLAN**  
SCALE: 1" = 20'